


FOR VIEWING PURPOSES, THIS DRAWING IS NOT TO SCALE

REVISIONS

| DESCRIPTION | DATE | APPROVAL |
|-------------|------|----------|
|-------------|------|----------|

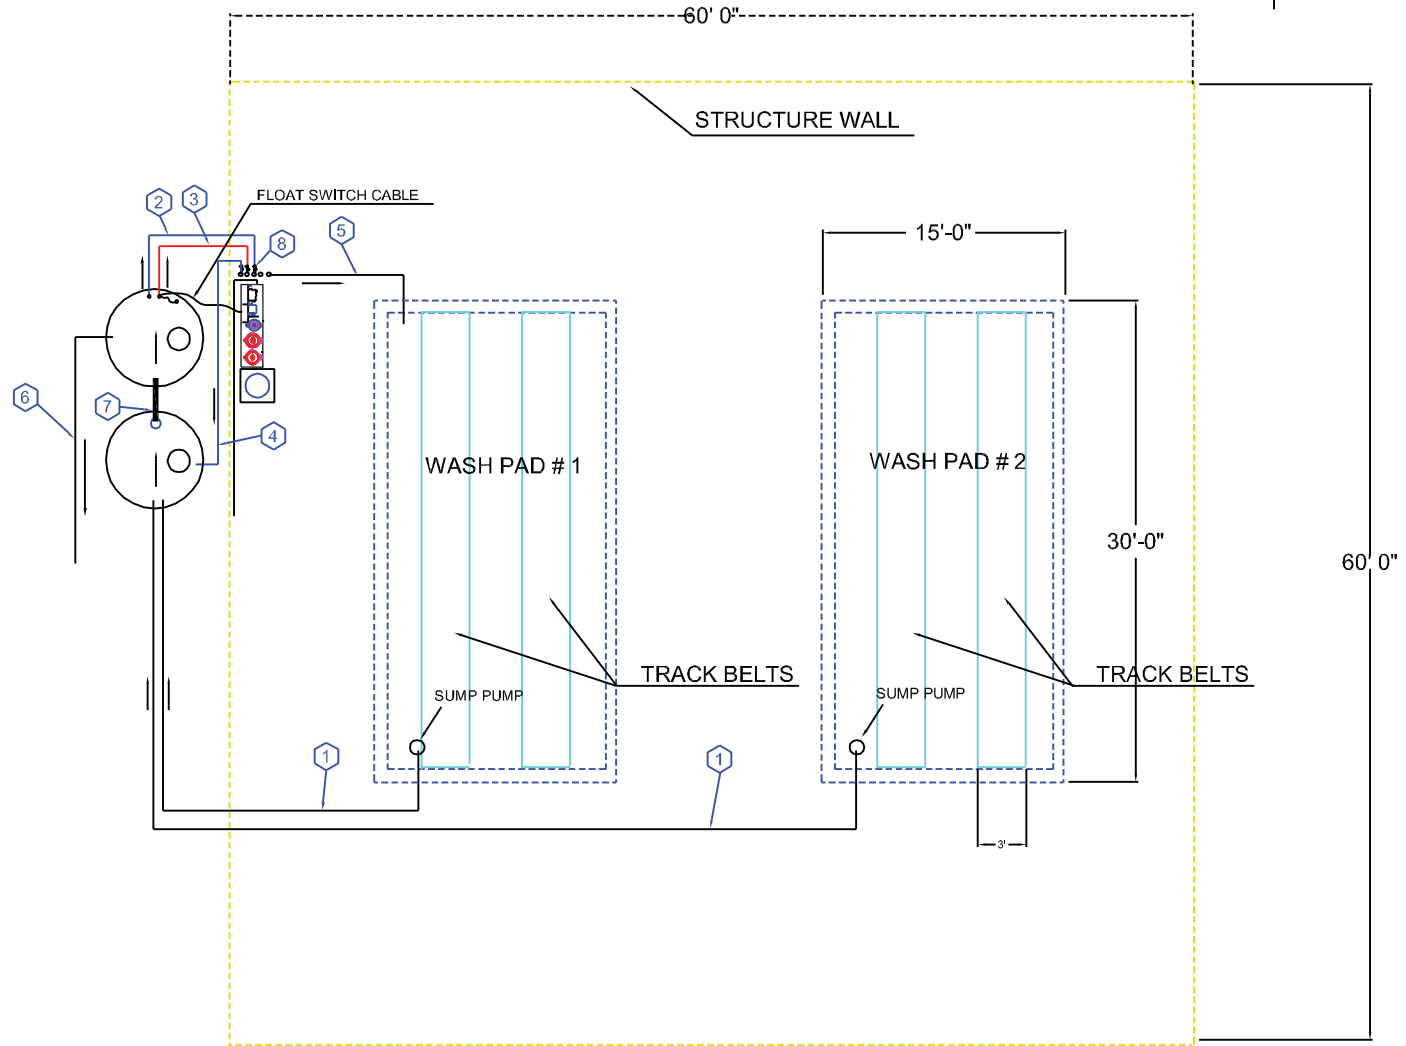

| CHECK OFF | RECLAIM SYSTEM PLUMBING SCHEDULE |
|--------------------------|--|
| <input type="checkbox"/> | ① 1.0" WASH PAD DRAIN (SUMP PUMP FEED) |
| <input type="checkbox"/> | ② 1.5" FILTER PUMP SUCTION |
| <input type="checkbox"/> | ③ 1.5" OZONE PUMP SUCTION |
| <input type="checkbox"/> | ④ 1.0" OZONE RETURN |
| <input type="checkbox"/> | ⑤ 2.0" MULTI LINE RETURN, SLOPE TO WASH TRENCH |
| <input type="checkbox"/> | ⑥ 4.0" OVERFLOW TO SEWER, SEPTIC, LEACH BED OR HOLDING TANK |
| <input type="checkbox"/> | ⑦ 3.0' TANK INNERCONNECT, TERMINATE WITH TEE IN EXITING TANK |
| <input type="checkbox"/> | ⑧ 1.5" FRESH WATER IN (AUTO BYPASS) |

FLOW DIAGRAM. ACTUAL PLACEMENT OF EQUIPMENT AND PLUMBING IS AT INSTALLERS DISCRETION

INSTALLER/PLUMBER IS RESPONSIBLE FOR CONFORMING TO ANY APPLICABLE CODE REQUIREMENTS

| | | | |
|-------|-----|------|---------|
| DRAWN | DLT | DATE | 4/13/09 |
| ENGR. | HET | DATE | 4/13/09 |

| | |
|--|-----------|
| API WASH WATER RECLAIM SYSTEM FLOW DIAGRAM | |
| PROJECT: | |
| DWG. NO. | REV A |
| SIZE | SCALE NTS |
| SHEET | OF |